

Eden Build Ltd.  
 135 South Dr  
 St Catharines, ON  
 info@edenbuild.ca  
 (905) 658-3336

**CLIENT**


**PROJECT**  
 Basement Remodel

**ISSUE**  
 February 6, 2024

**PROJECT NO.**  
 149

**DRAWN BY**  
 Craig Eden

**Existing Plan**

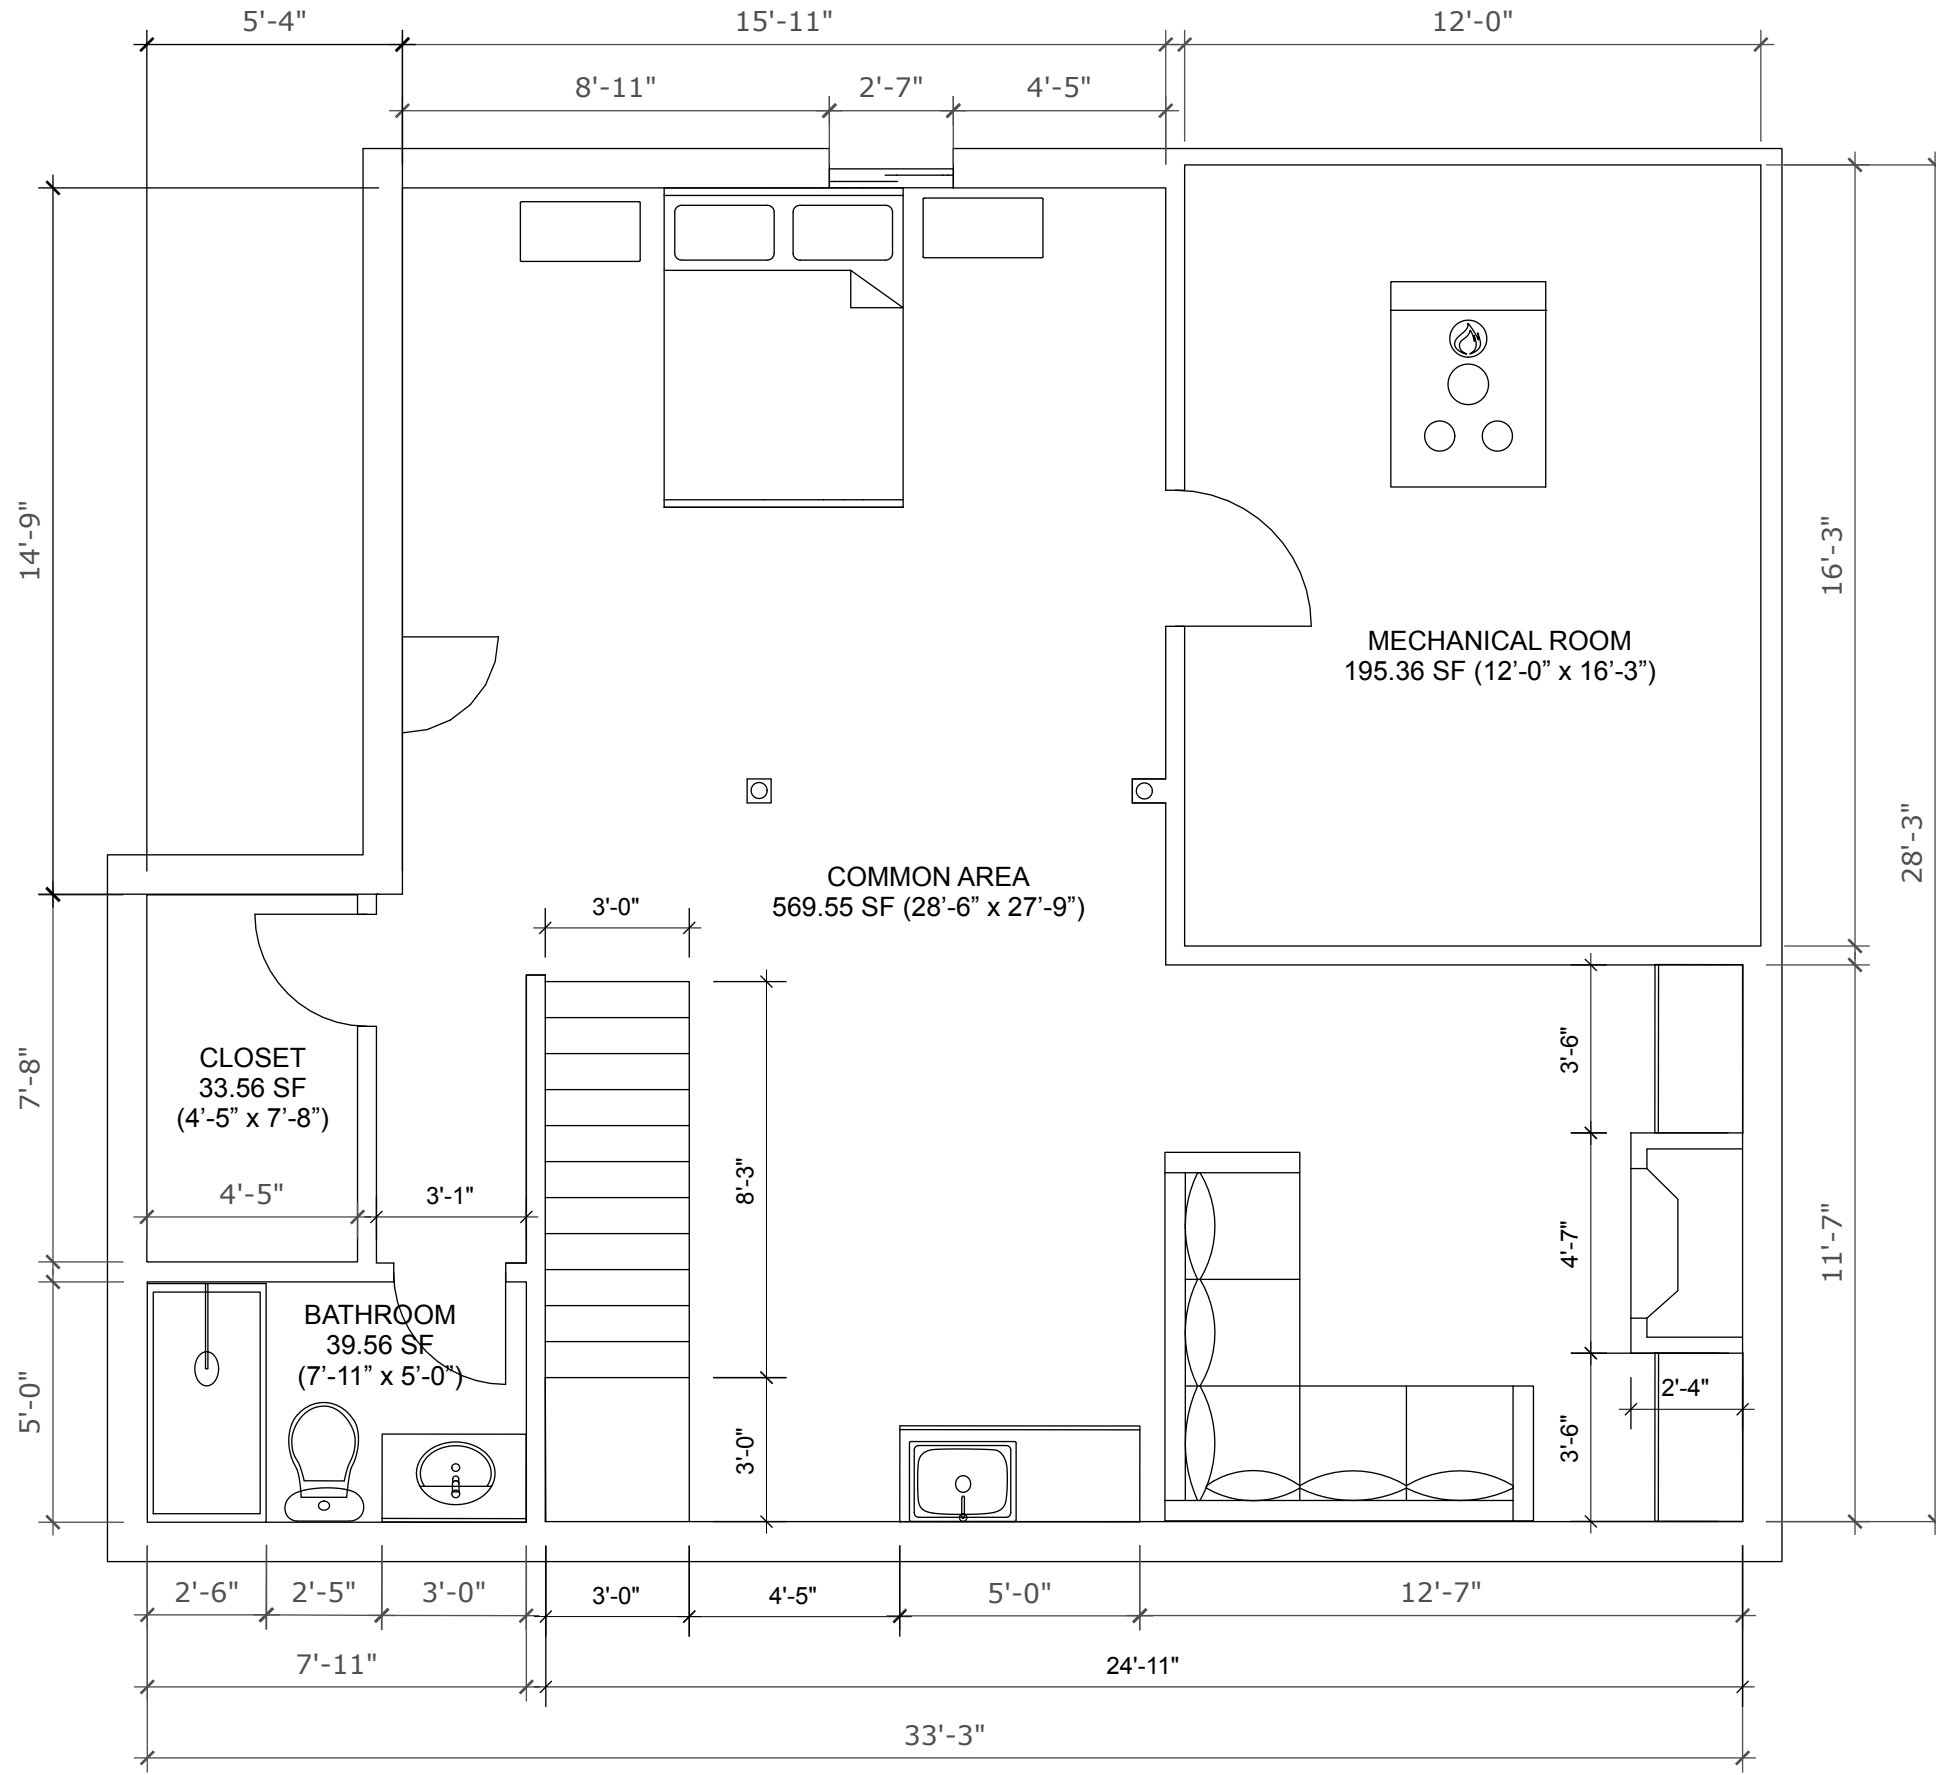

Eden Build Ltd.  
 135 South Dr  
 St Catharines, ON  
 info@edenbuild.ca  
 (905) 658-3336

CLIENT

PROJECT  
 Basement Remodel


ISSUE  
 February 6, 2024

DRAWN BY  
 Craig Eden

PROJECT NO.  
 149

Proposed Plan

A.02

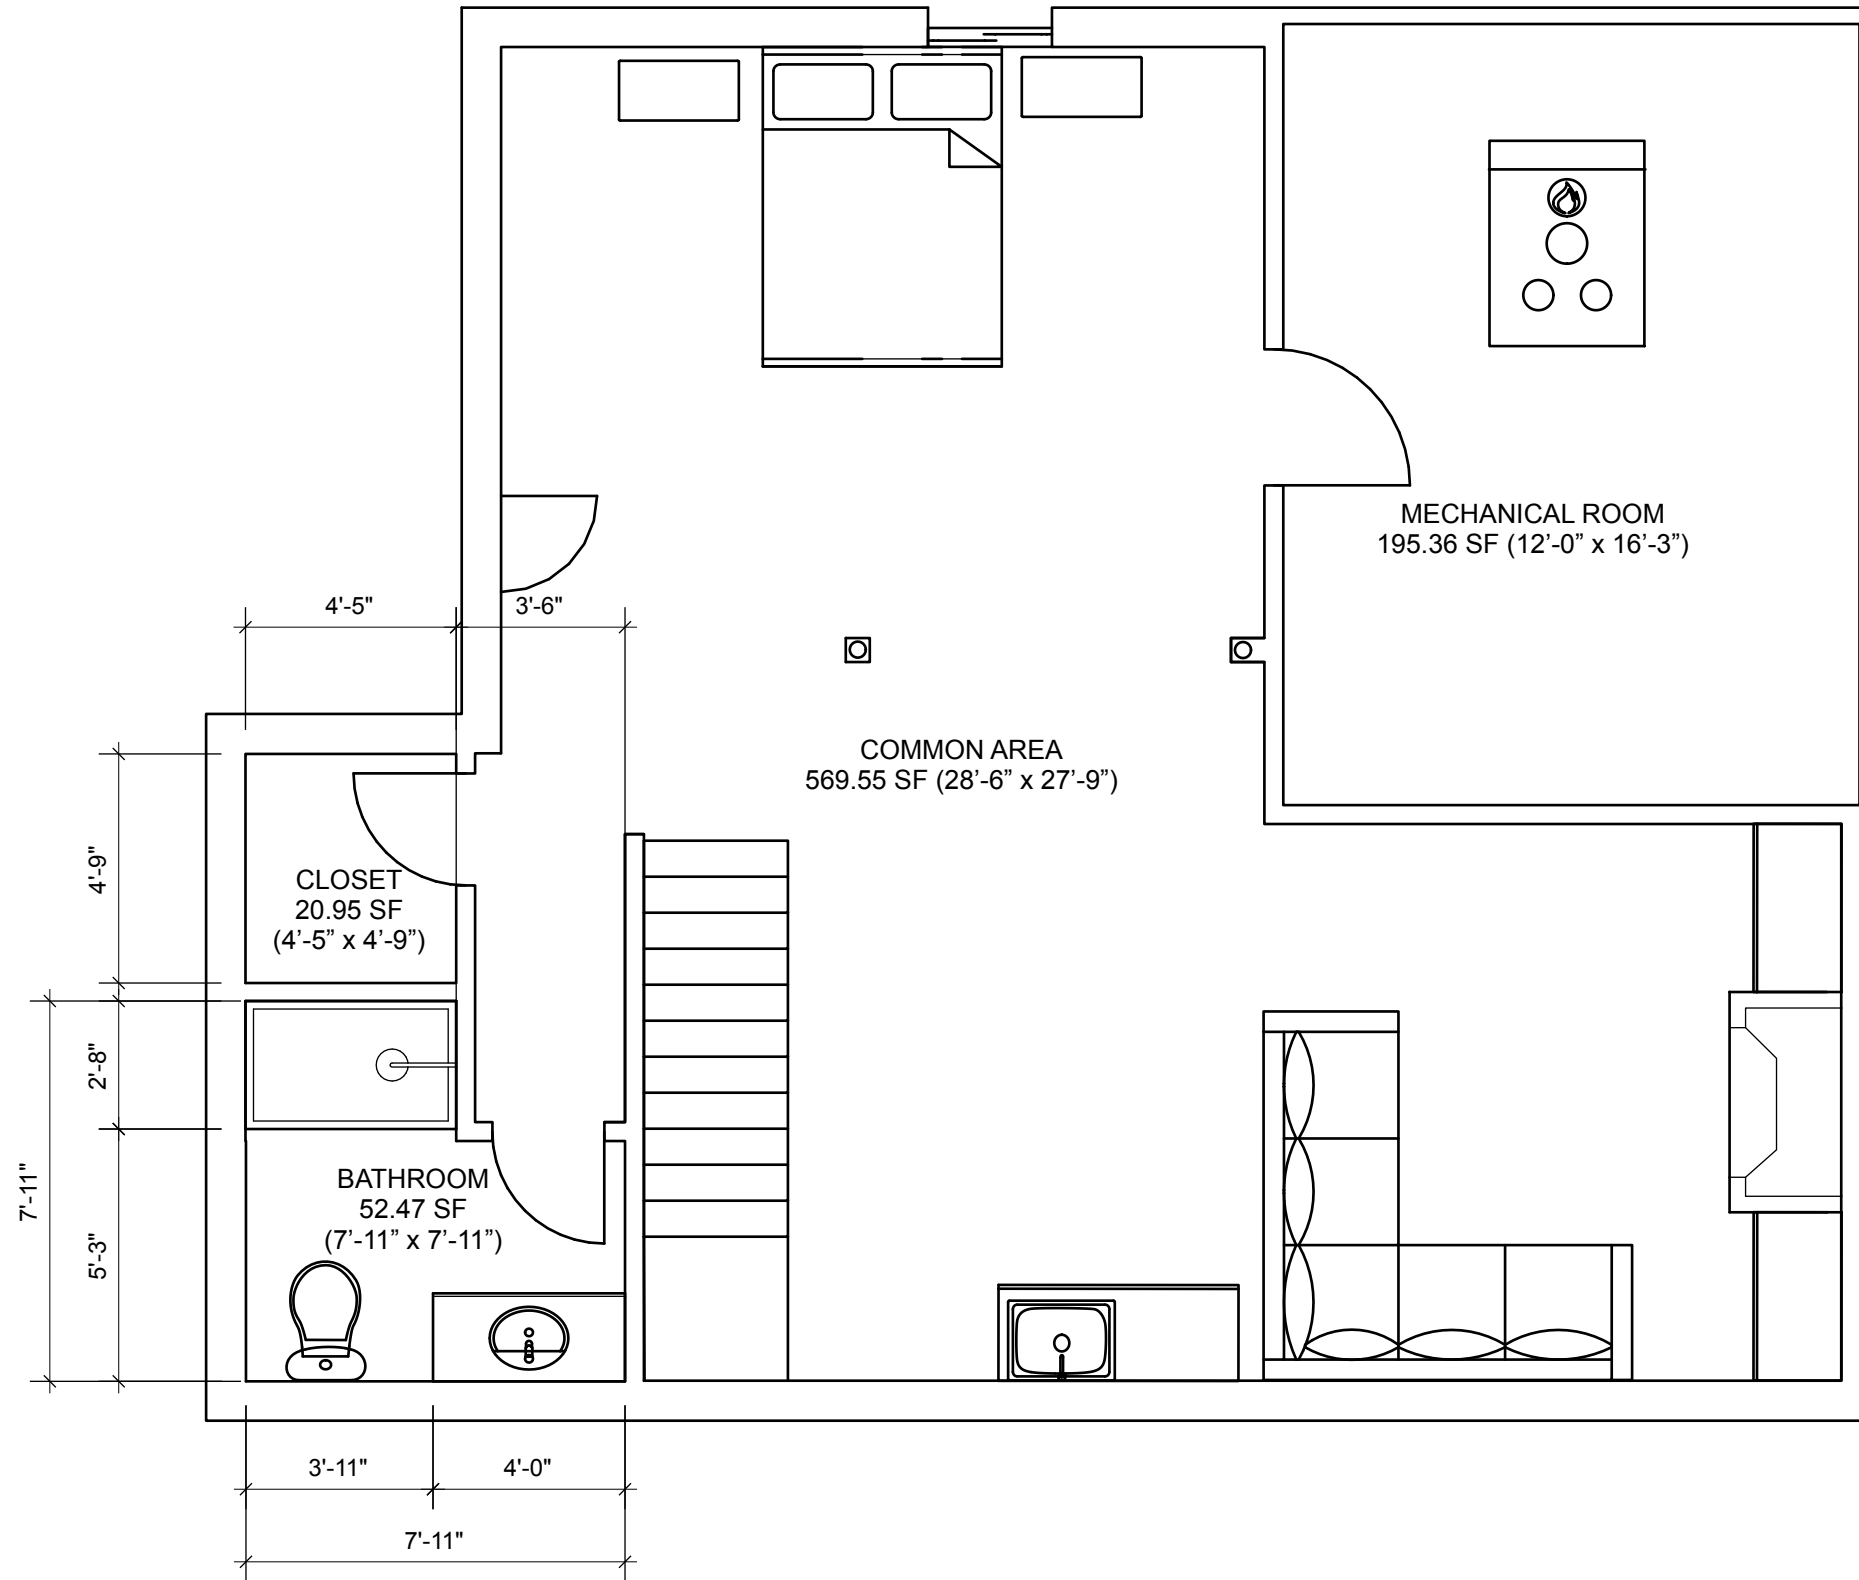

Eden Build Ltd.  
 135 South Dr  
 St Catharines, ON  
 info@edenbuild.ca  
 (905) 658-3336

CLIENT


PROJECT  
 Basement Remodel

ISSUE  
 February 6, 2024

DRAWN BY  
 Craig Eden

PROJECT NO.  
 149

# Larger Bathroom

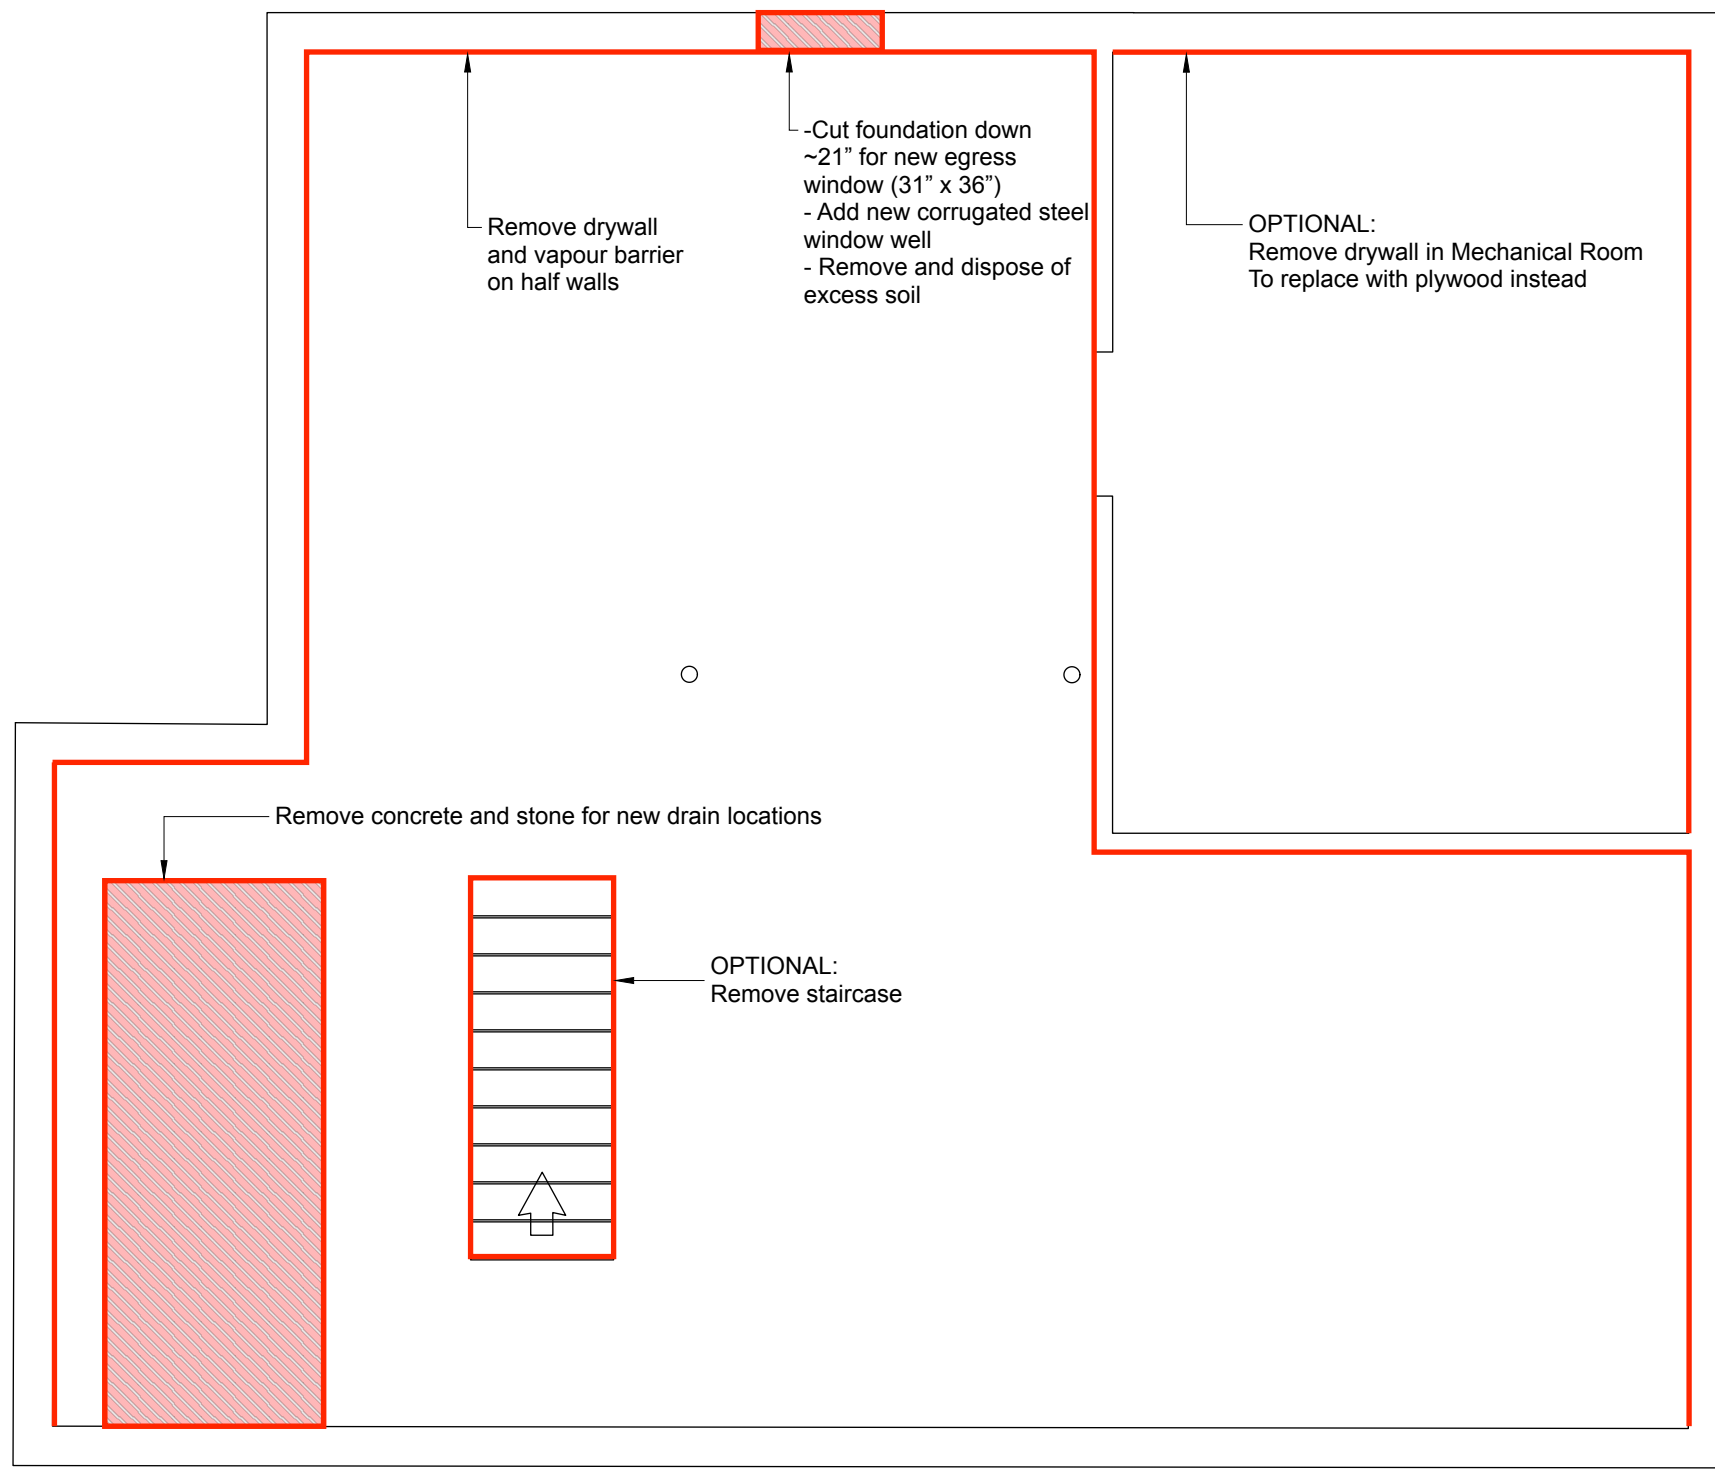

Eden Build Ltd.  
 135 South Dr  
 St Catharines, ON  
 info@edenbuild.ca  
 (905) 658-3336

CLIENT


PROJECT  
 Basement Remodel

PROJECT NO.  
 149

ISSUE  
 February 6, 2024

DRAWN BY  
 Craig Eden

# Demolition Plan

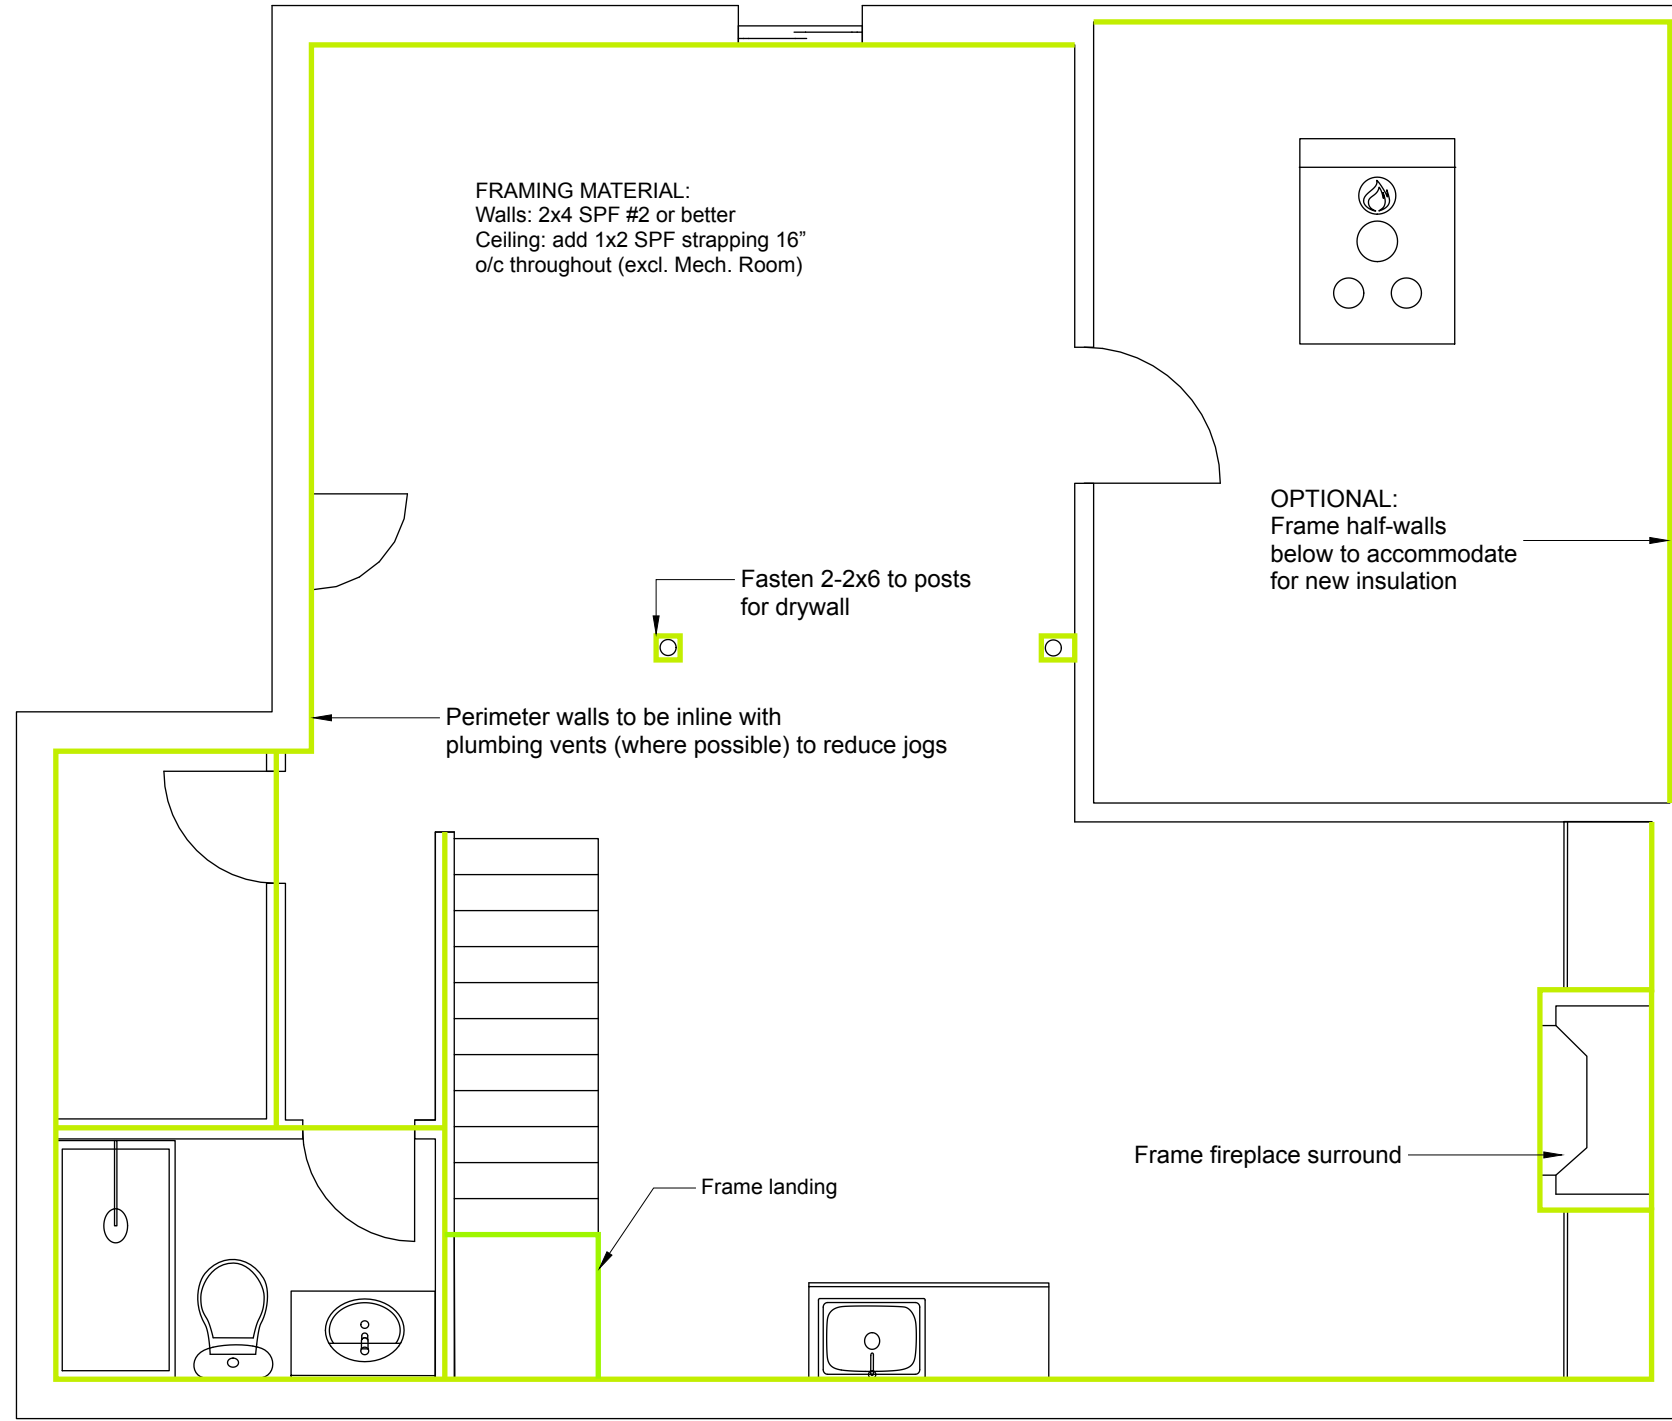

Eden Build Ltd.  
 135 South Dr  
 St Catharines, ON  
 info@edenbuild.ca  
 (905) 658-3336

**CLIENT**


**PROJECT**  
 Basement Remodel


**PROJECT NO.**  
 149

**ISSUE**  
 February 6, 2024

**DRAWN BY**  
 Craig Eden

**Framing Plan**

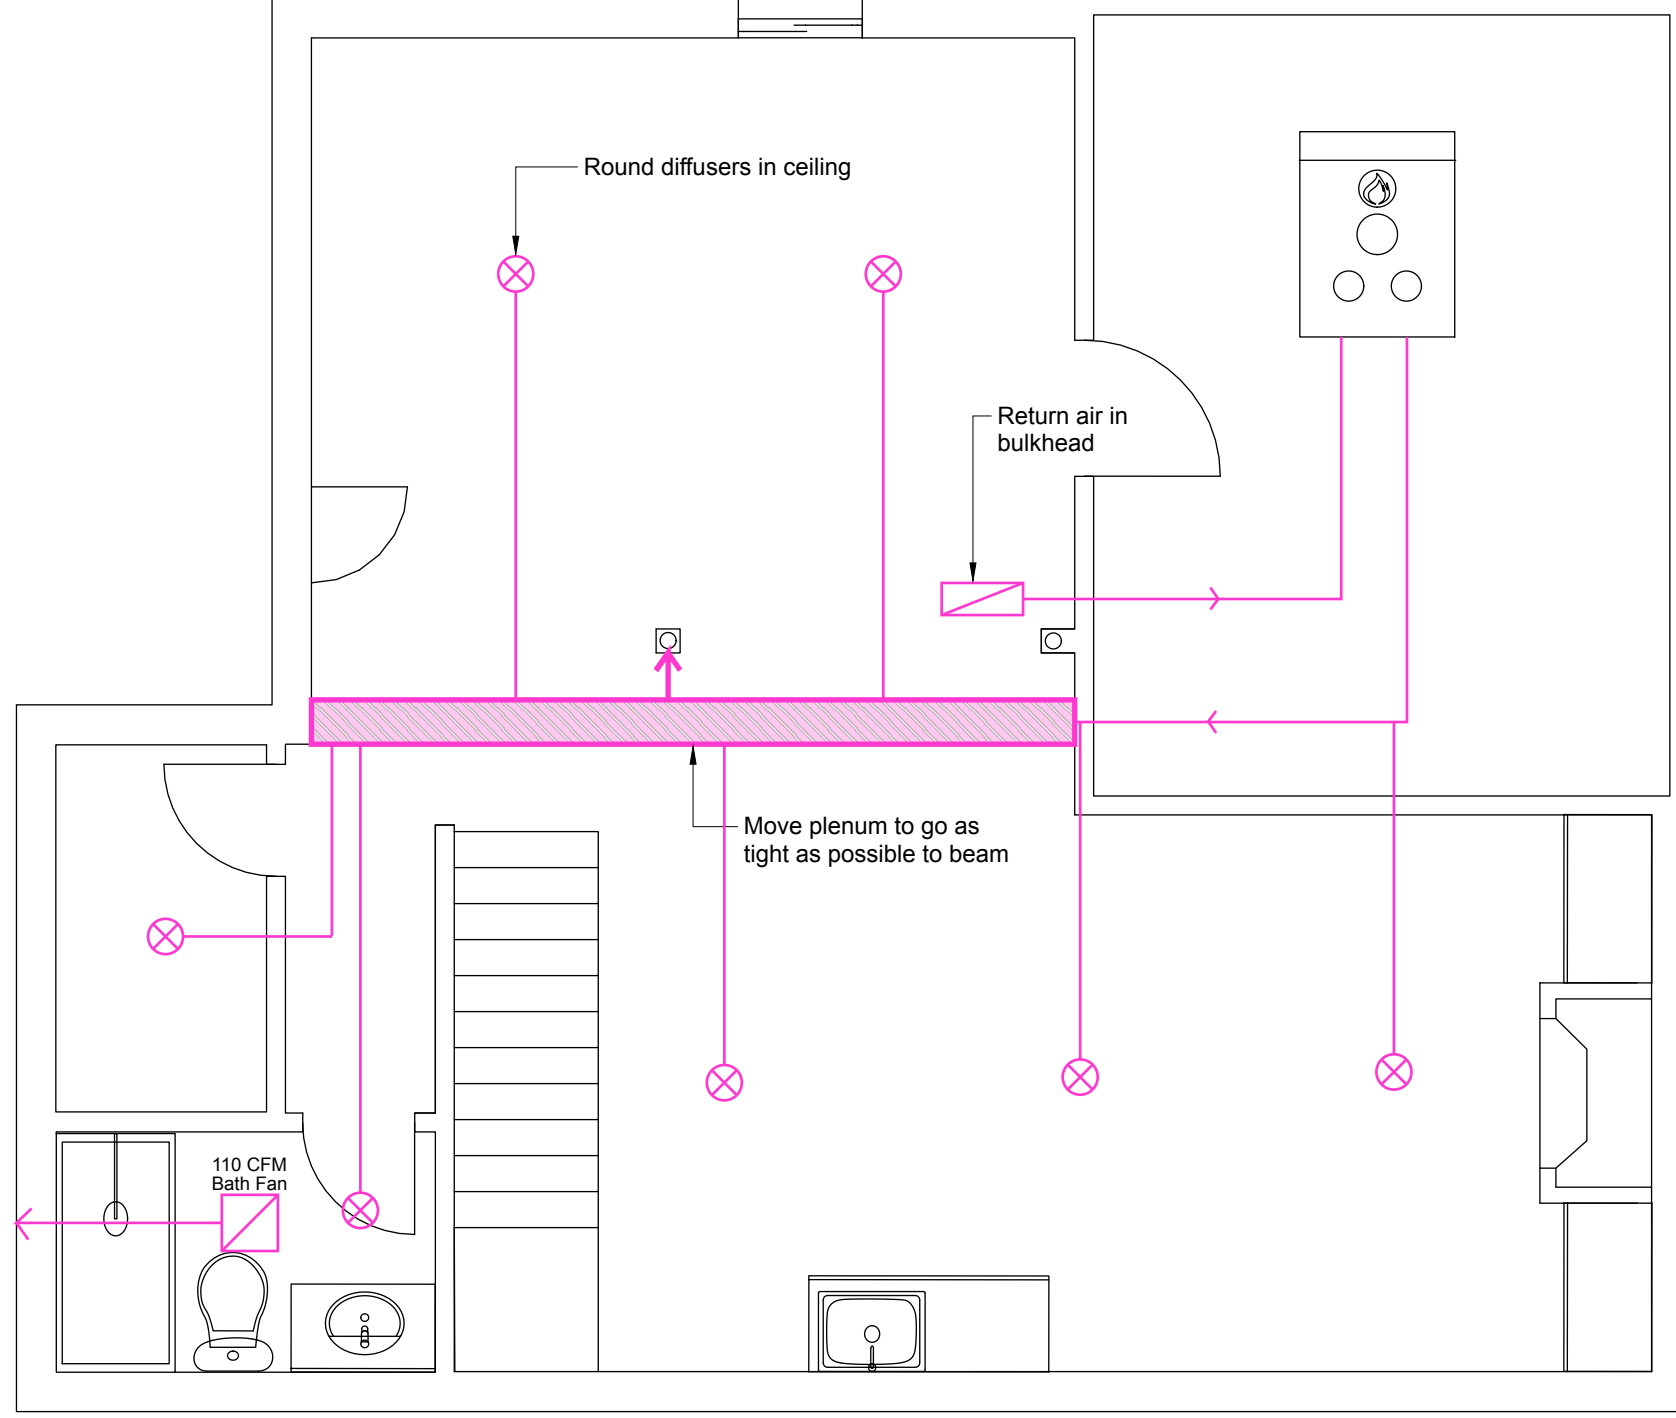

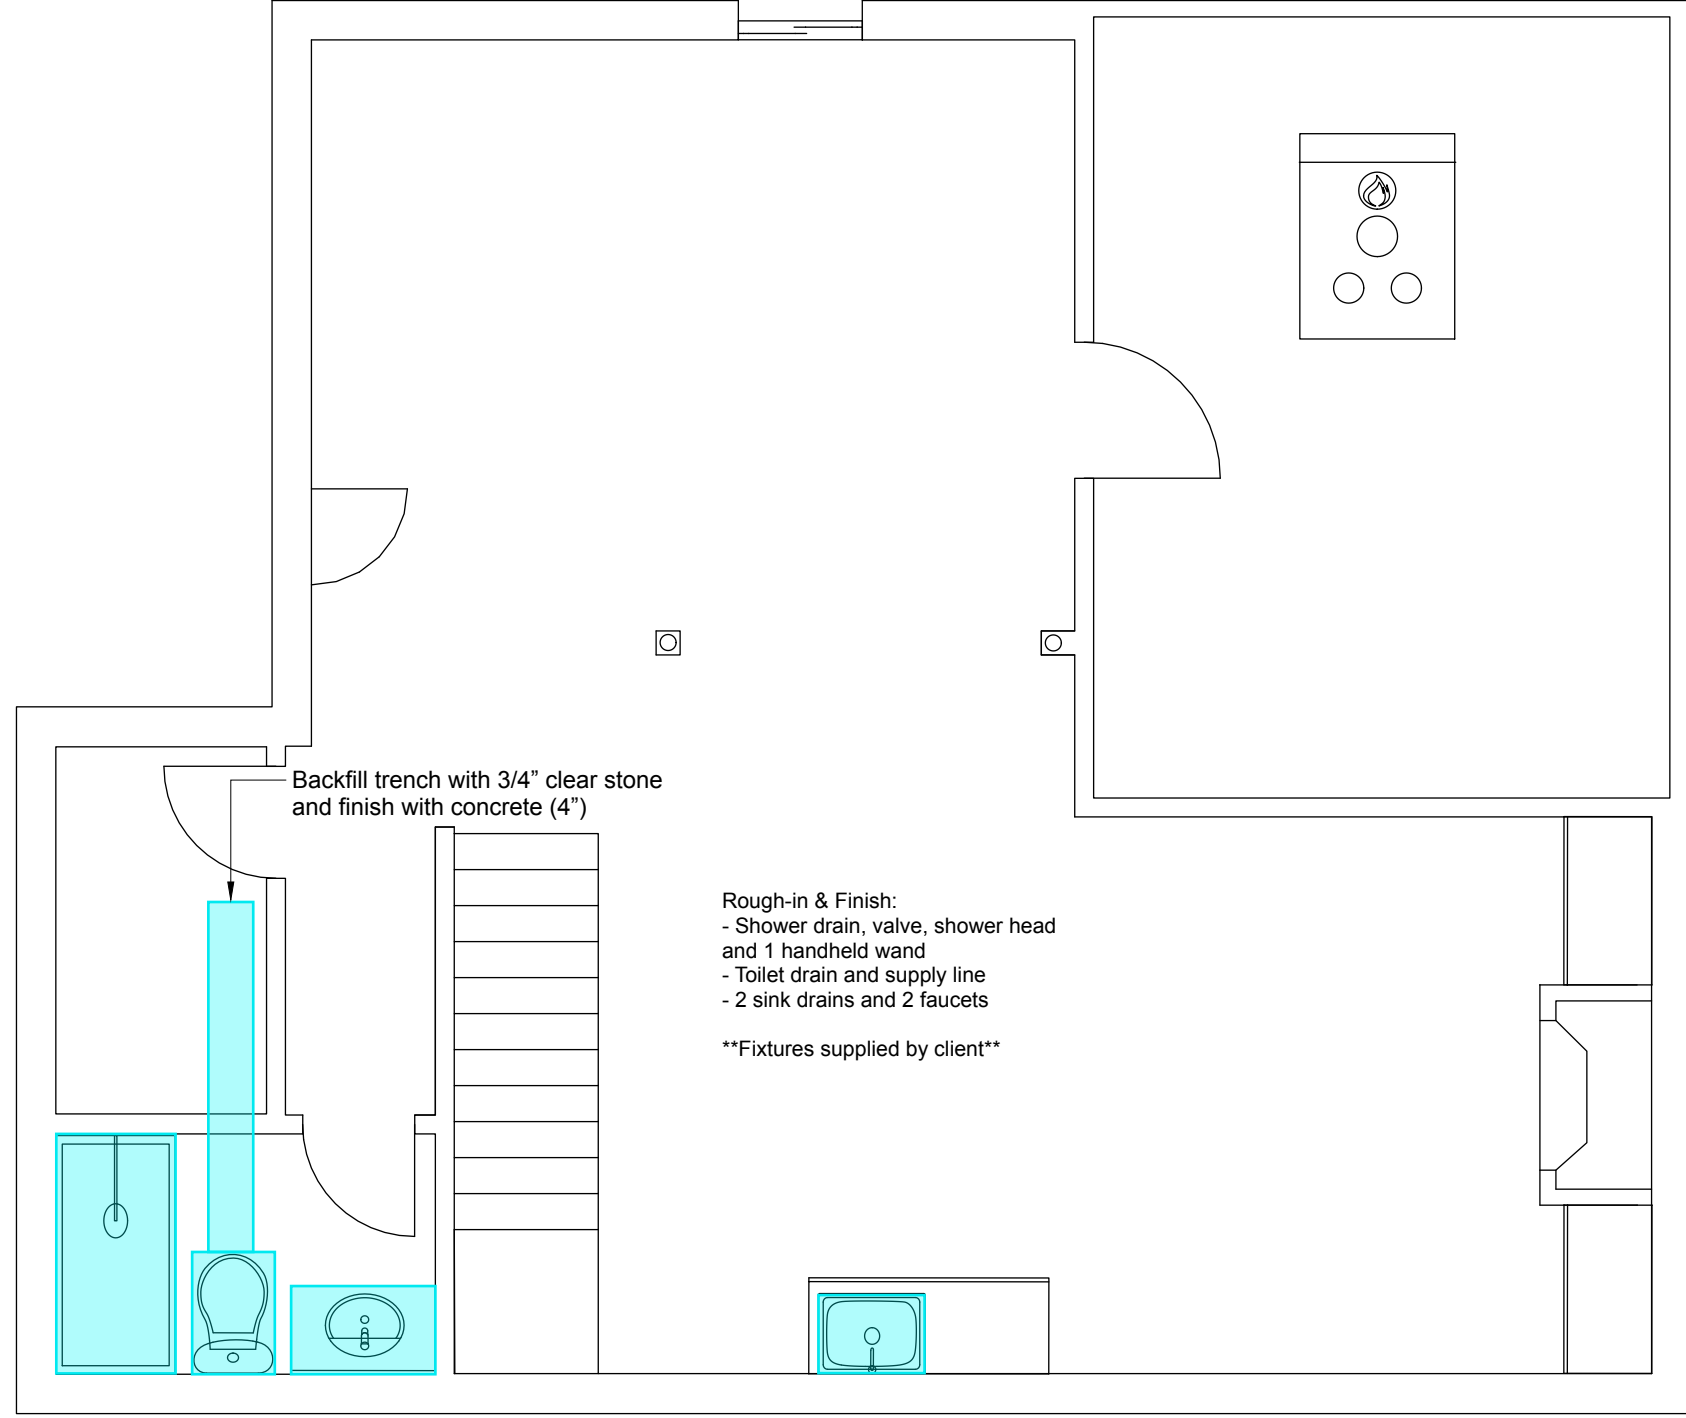

**Eden Build Ltd.**  
 135 South Dr  
 St Catharines, ON  
 info@edenbuild.ca  
 (905) 658-3336

**CLIENT**


**PROJECT**  
 Basement Remodel

**PROJECT NO.**  
 149

**ISSUE**  
 February 6, 2024

**DRAWN BY**  
 Craig Eden

**Plumbing Plan**

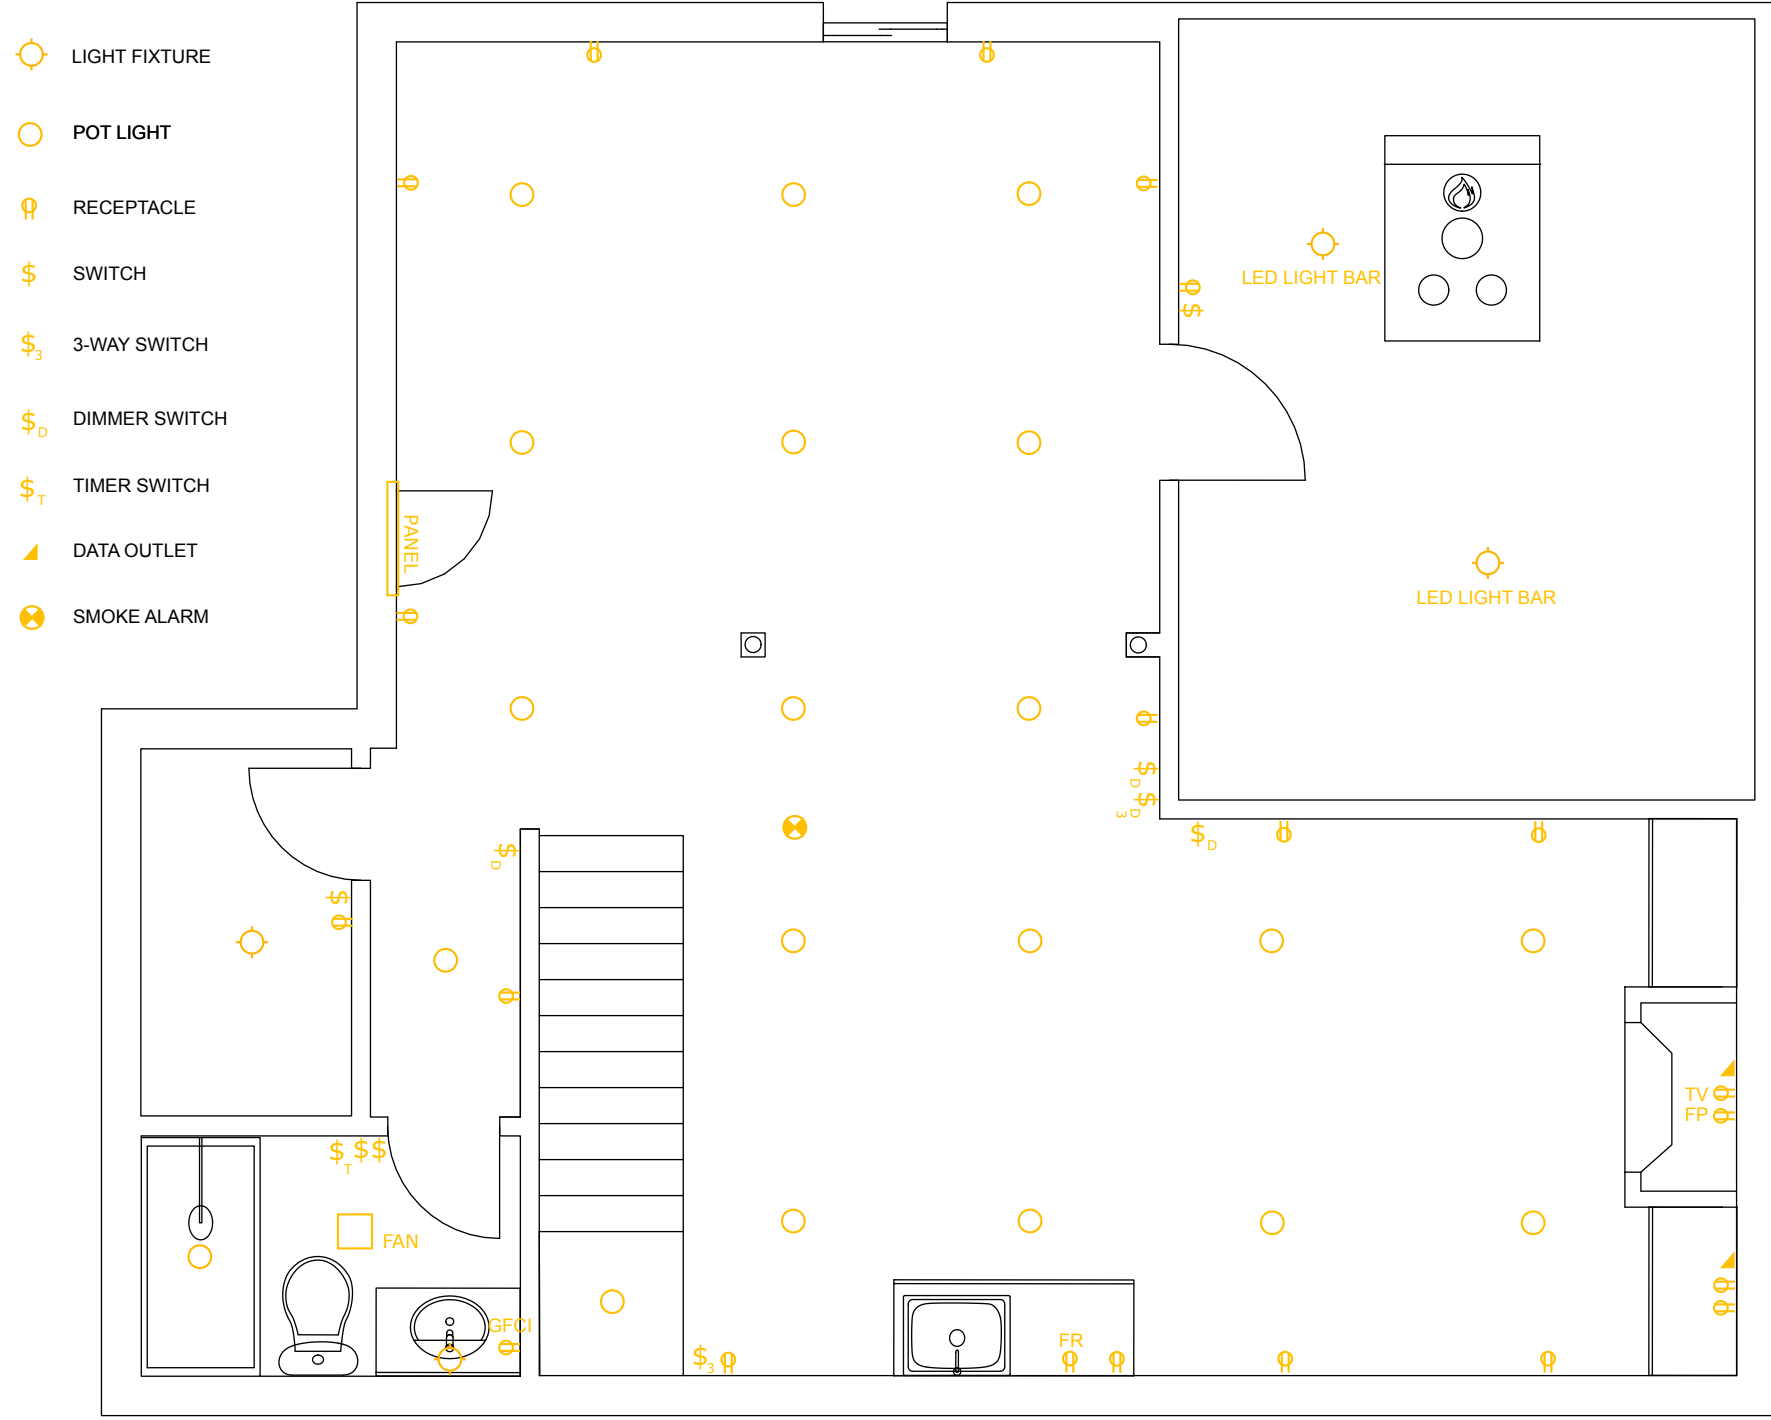

Eden Build Ltd.  
 135 South Dr  
 St Catharines, ON  
 info@edenbuild.ca  
 (905) 658-3336

CLIENT

PROJECT  
 Basement Remodel


ISSUE  
 February 6, 2024

DRAWN BY  
 Craig Eden

Electrical Plan

A.08



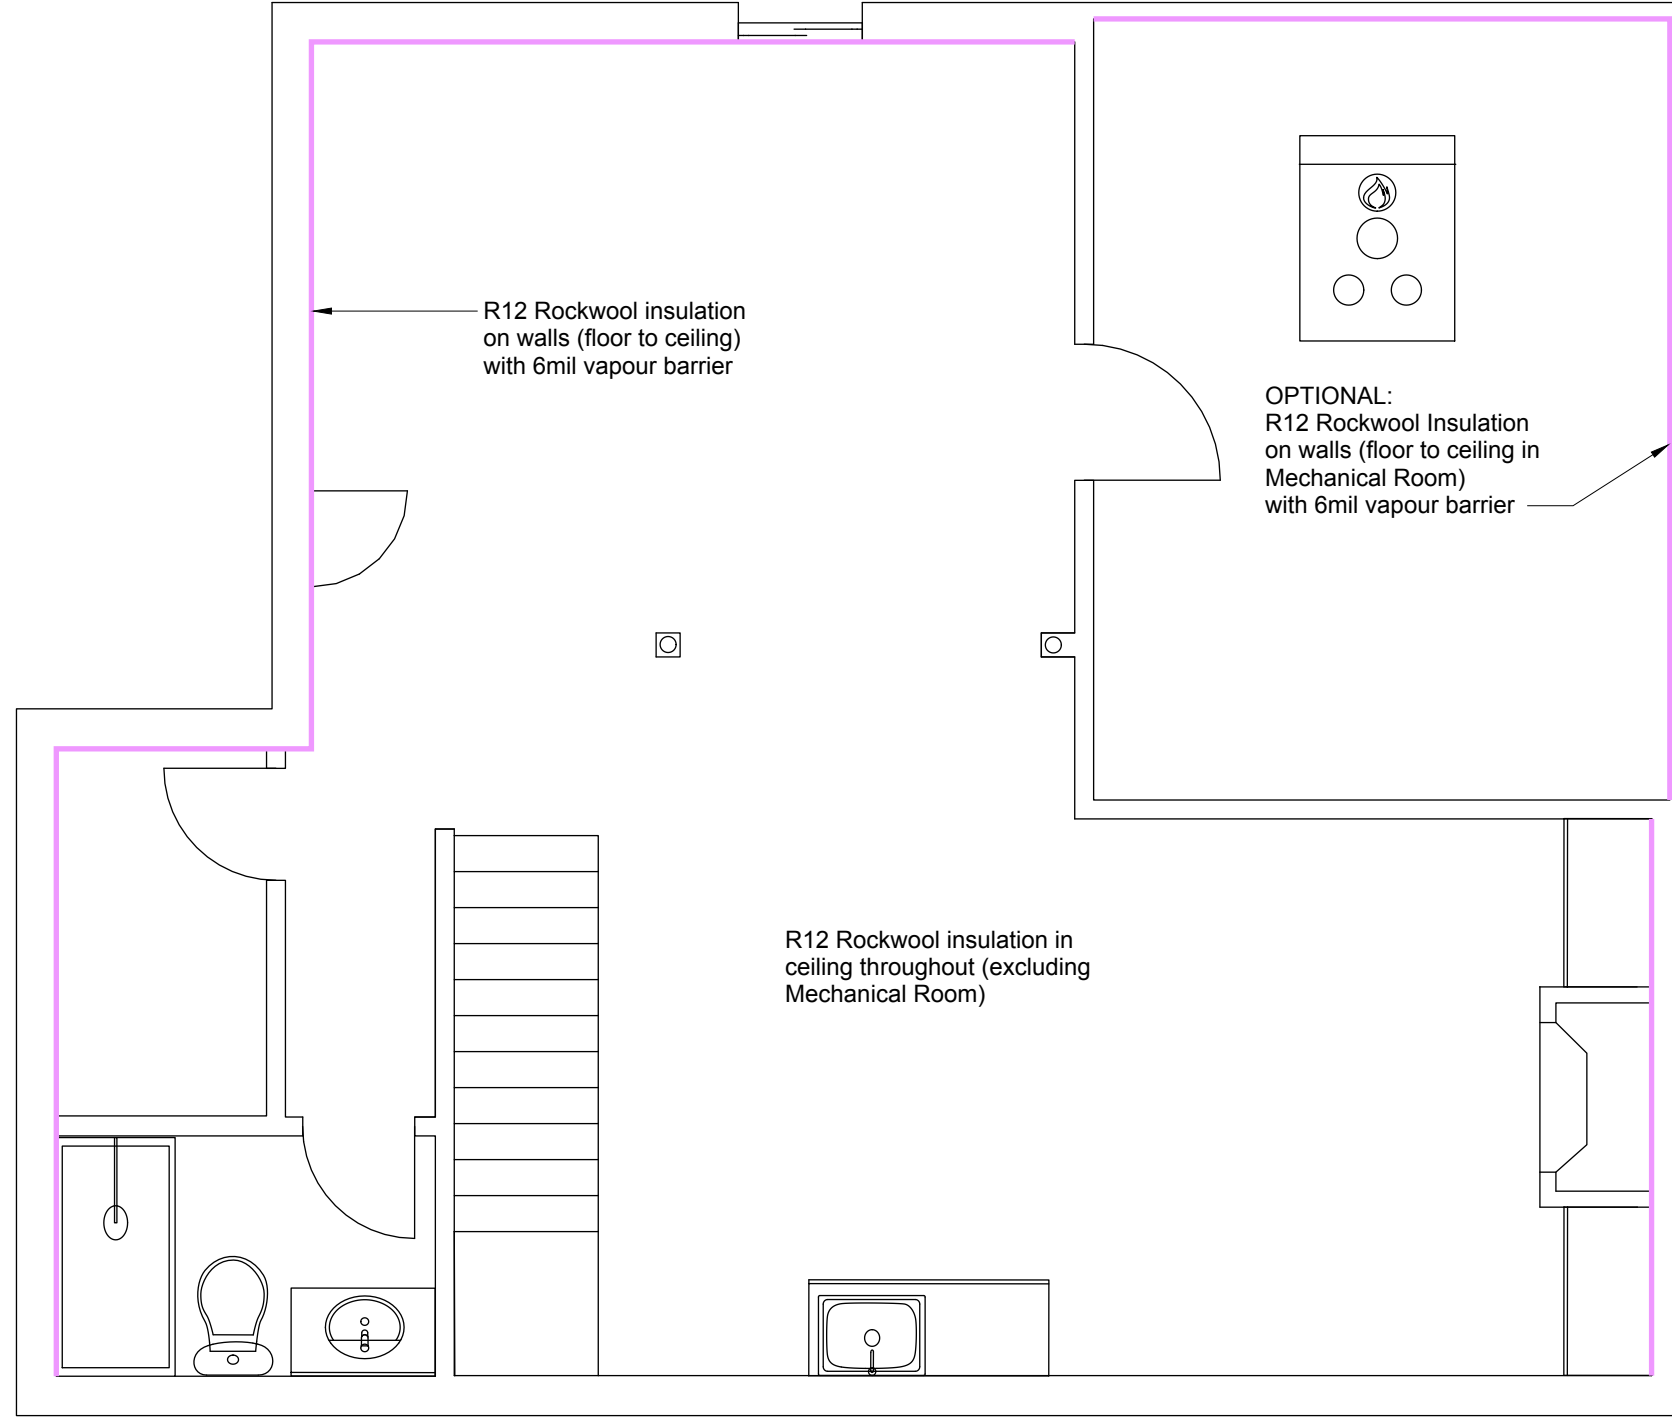

Eden Build Ltd.  
 135 South Dr  
 St Catharines, ON  
 info@edenbuild.ca  
 (905) 658-3336

CLIENT


PROJECT  
 Basement Remodel

ISSUE  
 February 6, 2024

DRAWN BY  
 Craig Eden

PROJECT NO.  
 149

# Insulation Plan

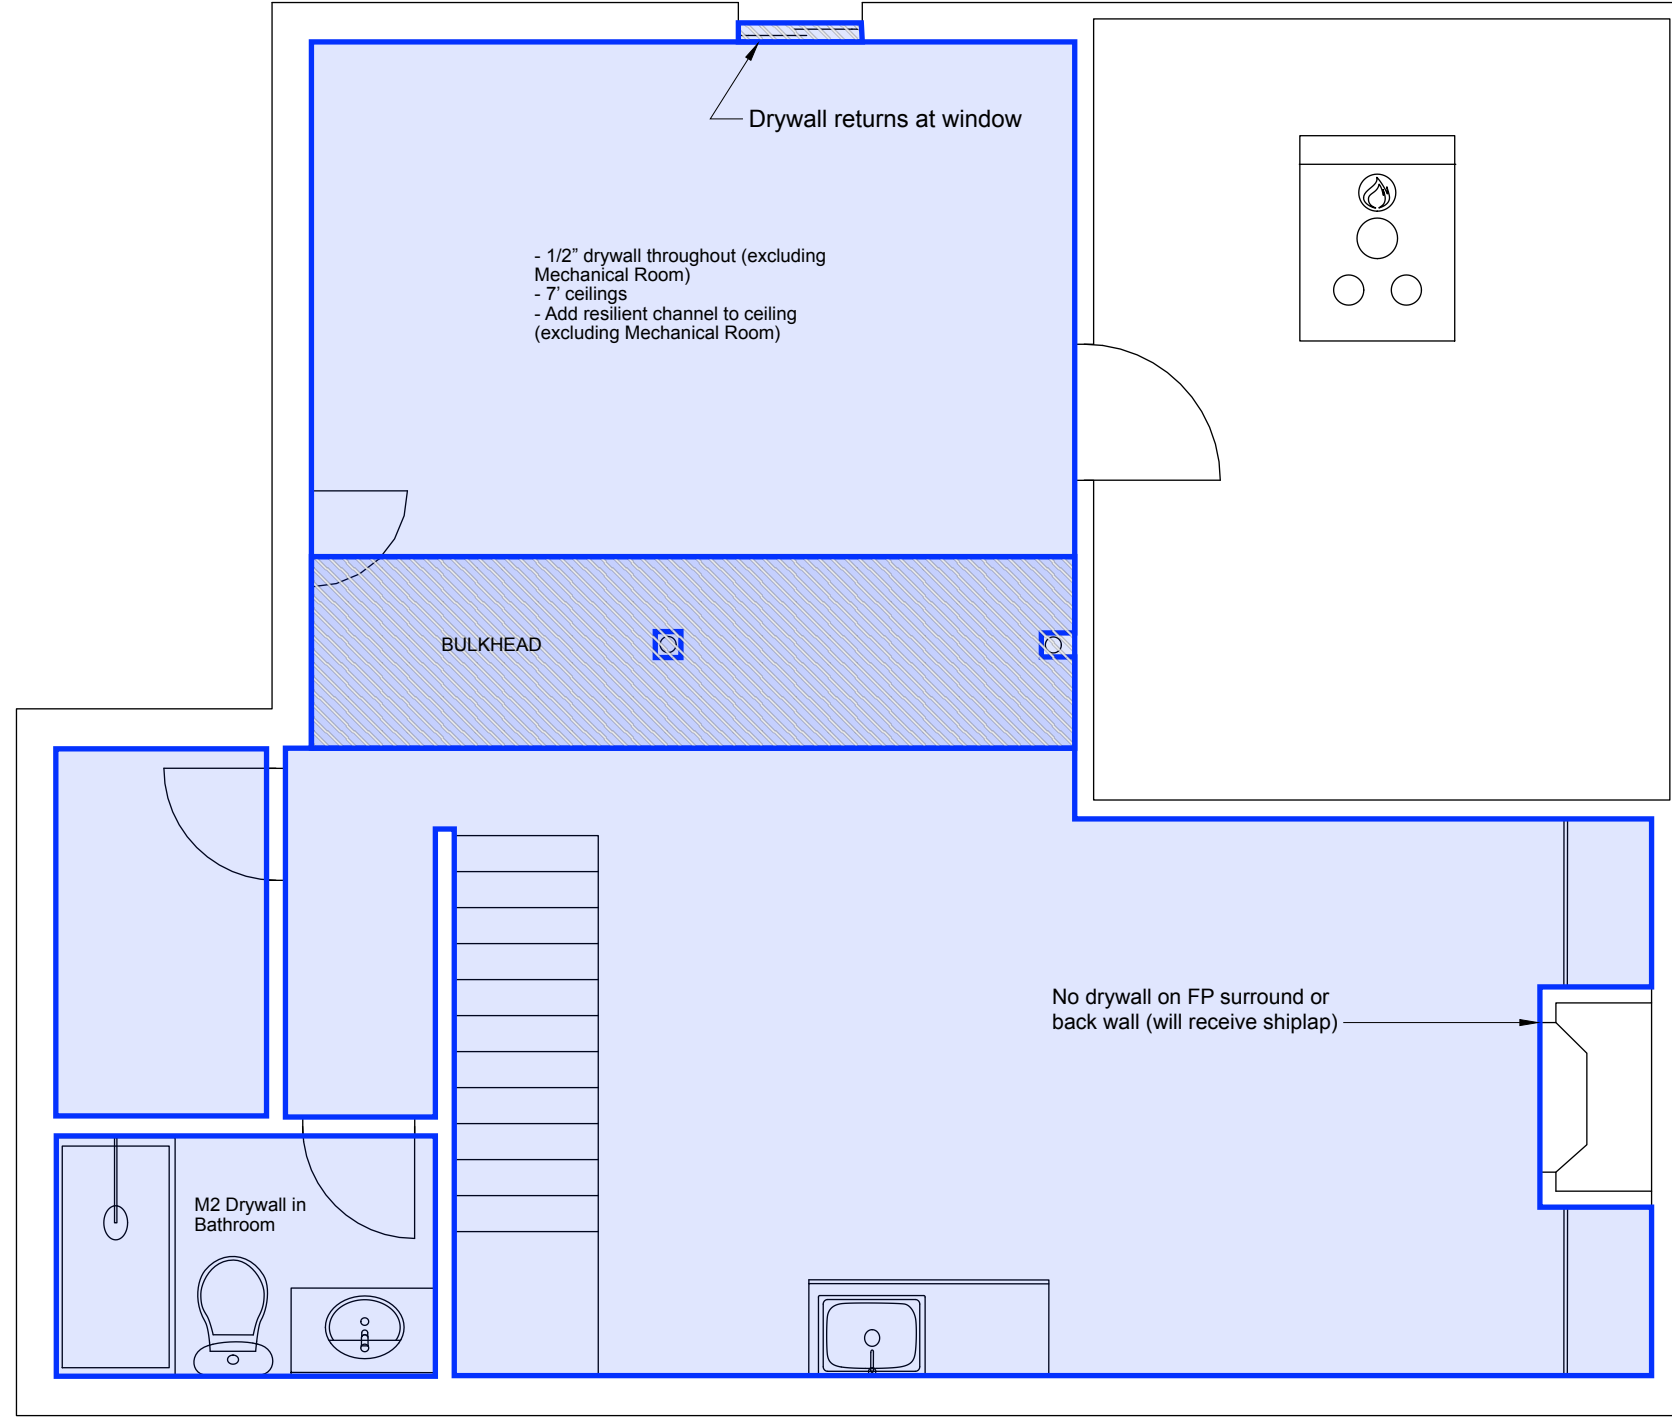

Eden Build Ltd.  
 135 South Dr  
 St Catharines, ON  
 info@edenbuild.ca  
 (905) 658-3336

CLIENT


PROJECT  
 Basement Remodel

ISSUE  
 February 6, 2024

DRAWN BY  
 Craig Eden

PROJECT NO.  
 149

# Drywall Plan

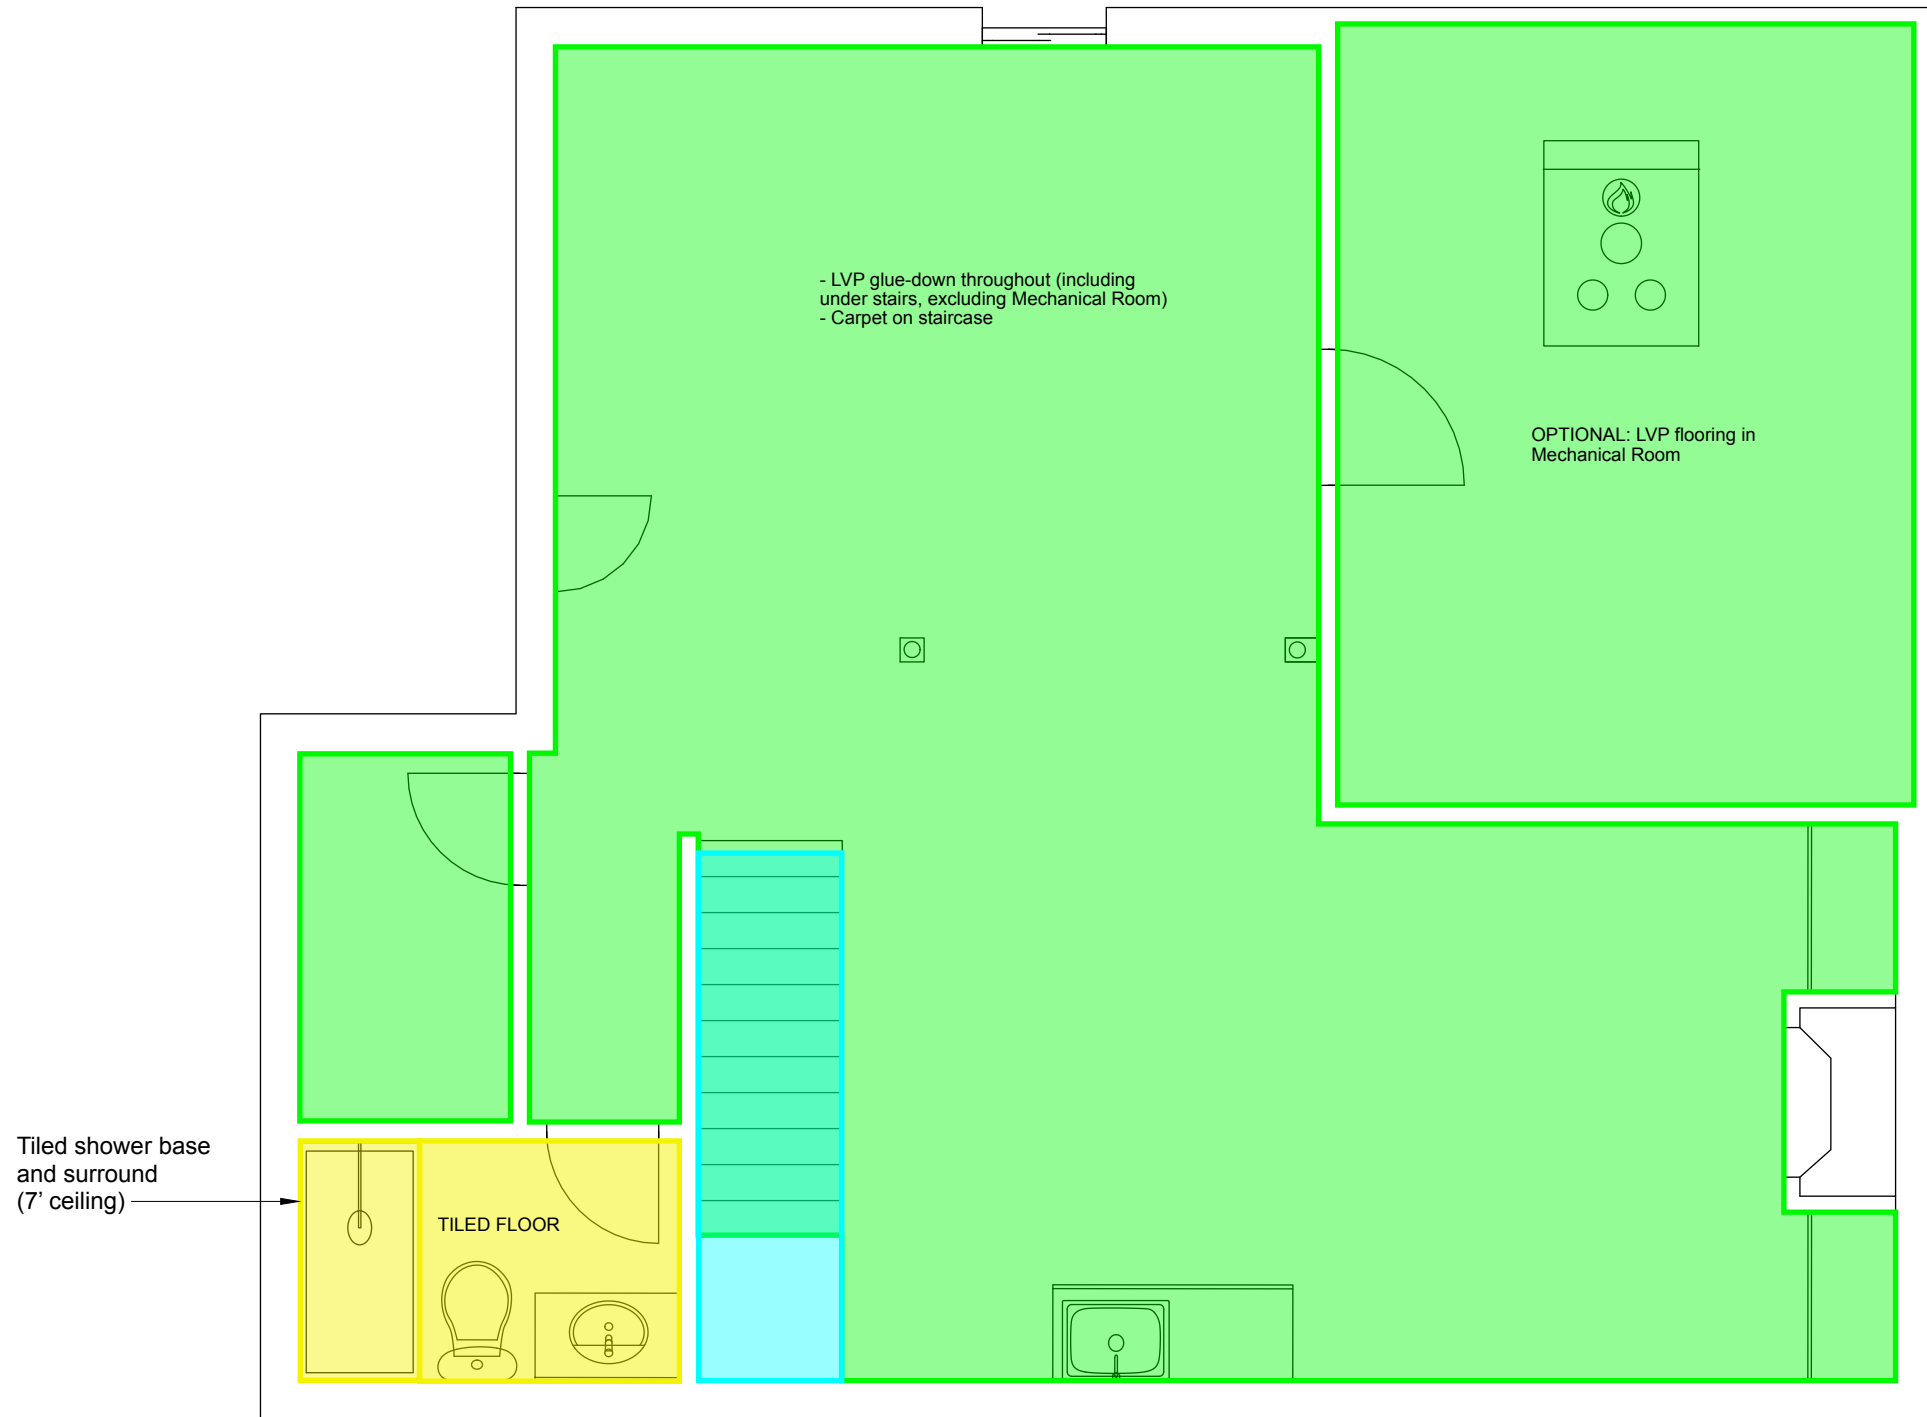

Eden Build Ltd.  
 135 South Dr  
 St Catharines, ON  
 info@edenbuild.ca  
 (905) 658-3336

CLIENT


PROJECT  
 Basement Remodel

ISSUE  
 February 6, 2024

DRAWN BY  
 Craig Eden

PROJECT NO.  
 149

# Flooring Plan

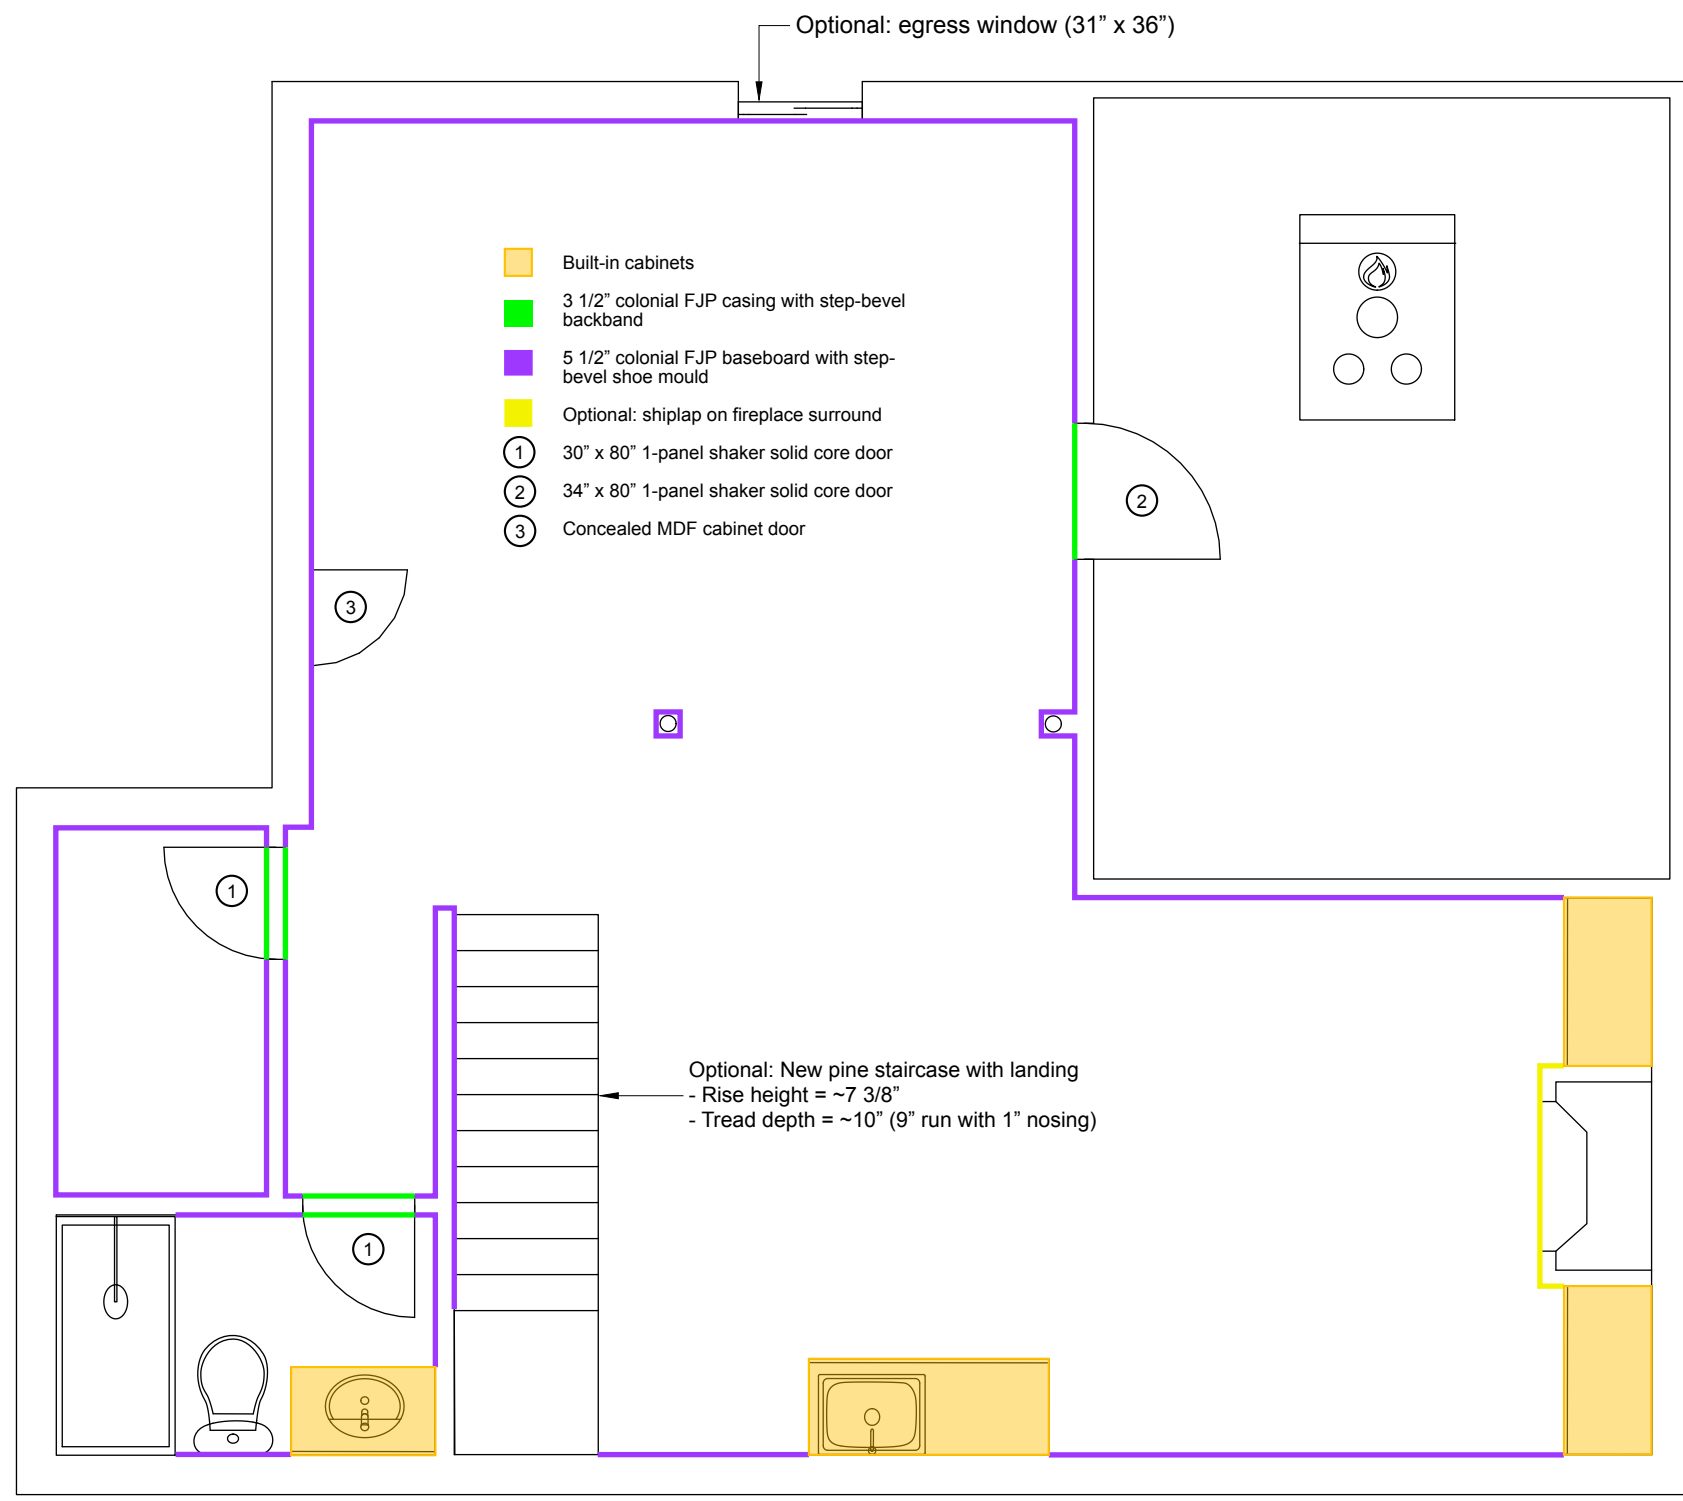

**Eden Build Ltd.**  
 135 South Dr  
 St Catharines, ON  
 info@edenbuild.ca  
 (905) 658-3336

**CLIENT**  
 ...


**PROJECT**  
 Basement Remodel

**PROJECT NO.**  
 149

**ISSUE**  
 February 6, 2024

**DRAWN BY**  
 Craig Eden

**Millwork Plan**

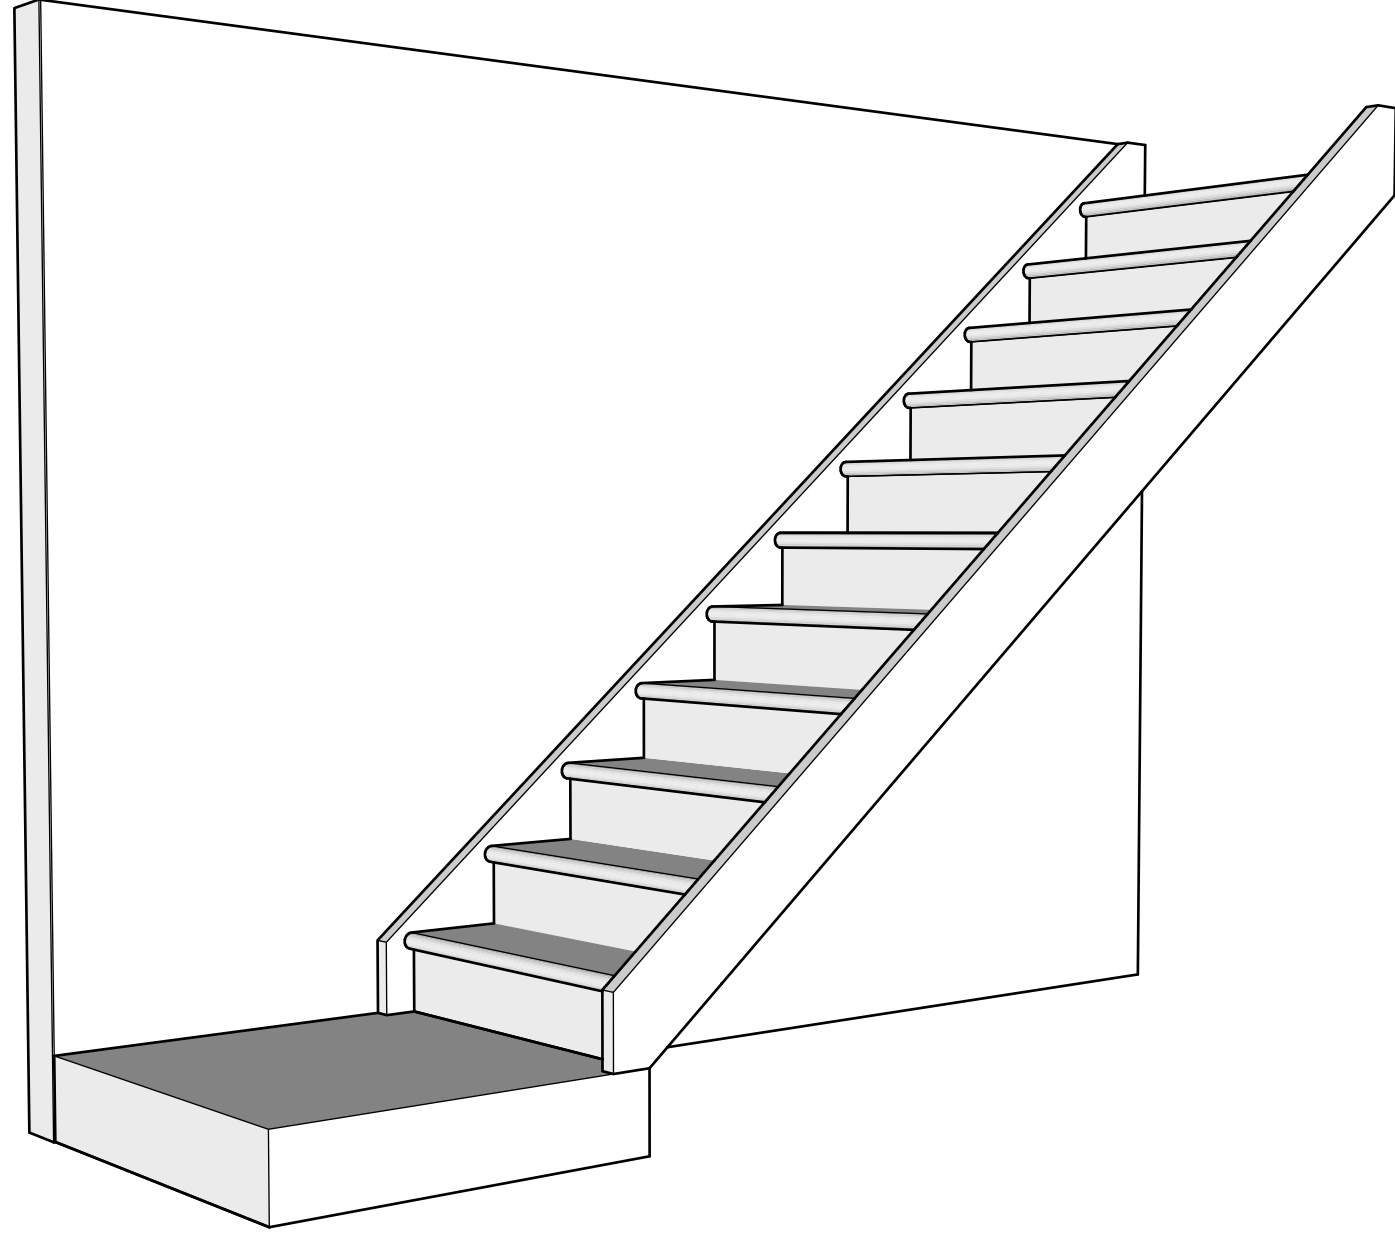

Stair Perspective

ISSUE  
February 6, 2024

DRAWN BY  
Craig Eden

PROJECT  
Basement Remodel

PROJECT NO.  
149

CLIENT

Eden Build Ltd.  
135 South Dr  
St Catharines, ON  
info@edenbuild.ca  
(905) 658-3336

